

1 ELECTRICAL SITE PLAN

SCALE: 1" = 30'-0"



SHEET NOTES

NOTES:


1. PROVIDE CONCRETE PULLBOX COMPLETE WITH EXTENSION AND COVER, MARKED LID "ELECTRICAL". PRODUCT AS MANUFACTURED BY CHRISTY OR APPROVED EQUAL.
2. COORDINATE EXACT ROUTING OF DUCTBANK IN THE FIELD.
3. THE CONTRACTOR SHALL BE RESPONSIBLE TO INVESTIGATE AND VERIFY THE ACTUAL LOCATION AND DEPTH OF ALL EXISTING UNDERGROUND FACILITIES AT LEAST 48 HOURS IN ADVANCE OF THE PERFORMANCE OF ANY WORK. CALL (USA) UNDERGROUND SERVICE ALERT. TEL#: 800-227-2600 BEFORE TRENCHING
4. CONTRACTOR TO BE COGNIZANT OF (H.V.) UG UTILITY LINE PRIOR TO EXCAVATION. COORDINATE WITH UTILITY CO AS NECESSARY PRIOR TO TRENCHING.
5. REPAIR TRENCH LINE TO MATCH (E) SURFACE, TYP. UON.
6. CONFIRM CONDUIT SIZE AND QUANTITY WITH DRAWING E3-SM.

KEYNOTES

- 1 PROVIDE CODE SIZE PULL BOX, SUITABLE FOR TRAFFIC LOADING, COMPLETED WITH EXTENSION AND STEEL COVER, COORDINATE EXACT LOCATION IN THE FIELD.
- 2 FOR ELECTRICAL SIGNAGE AND LOCATION SEE DWG. E11.
- 3 SEE ARCH. DWG. FOR EXACT LOCATION.

CONDUIT SCHEDULE

TAG	CONDUIT	FROM	TO
F1	(1) 1-1/4" C	CB "A1"	EQUIP PAD "A"
F2	(1) 1-1/4" C	CB "A2"	EQUIP PAD "A"
F3	(1) 1-1/4" C	CB "A3"	EQUIP PAD "A"
F4	(1) 1-1/4" C	CB "A4"	EQUIP PAD "A"
F5	(1) 1-1/2" C	CB "A5"	EQUIP PAD "A"
F6	(1) 1" C	CB "A6"	EQUIP PAD "A"
F7	(1) 3/4" C	CB "A7"	EQUIP PAD "A"
F8	(1) 1/2" C	CB "A8"	EQUIP PAD "A"
F9	(1) 3/4" C	CB "A9"	EQUIP PAD "A"
F10	(1) 4" C	EQUIP PAD "B"	EQUIP PAD "A"
F11	(2) 4" C	EQUIP PAD "A"	TIE-IN LOCATION

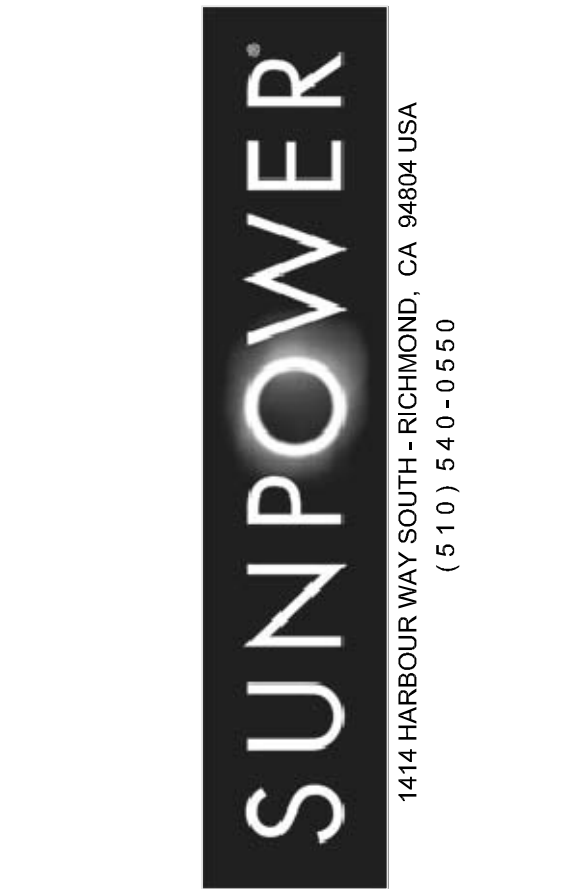


ITEM:	REVISIONS/ISSUE:	DATE:
1	DSA REVIEW	XX/XX/XX
	PG&E SUBMITTAL	10/12/11



www.atiae.com  
3860 Blackhawk Road Danville, CA 94506 T 925.648.8800  
2510 Douglas Boulevard Roseville, CA 95661 T 916.772.1800  
3050 Pullman Street Costa Mesa, CA 92626 T 714.338.1600  
1901 Orange Tree Lane Redlands, CA 92374 T 909.801.8160

PROFESSIONAL STAMP:

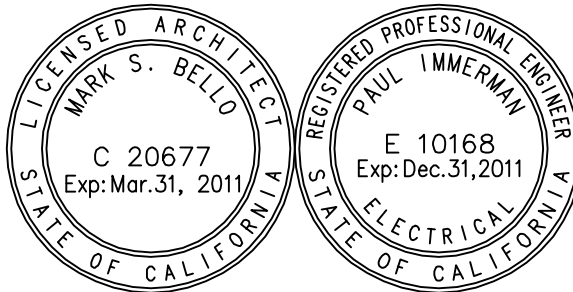

APPROVALS:

PROJECT TITLE:

SUNPOWER  
ELEVATED  
SOLAR CANOPY  
SEQUOIA  
MIDDLE SCHOOL  
MT. DIABLO UNIFIED  
SCHOOL DISTRICT

SHEET TITLE:

ELECTRICAL  
SITE  
PLAN

DATE: AS NOTED  
SCALE:  
DRAWN BY: JAG/AR  
CHECKED BY: PMI  
JOB NO.: SA8504.045  
CAD FILE: +E1\_SM\_Site.dwg  
SHEET NO:

E1-SM