

1 ELECTRICAL SITE PLAN

SCALE: 1" = 30'-0"



SHEET NOTES

NOTES:


1. PROVIDE CONCRETE PULLBOX COMPLETE WITH EXTENSION AND COVER, MARKED LID "ELECTRICAL". PRODUCT AS MANUFACTURED BY CHRISTY OR APPROVED EQUAL.
2. COORDINATE EXACT ROUTING OF DUCTBANK IN THE FIELD.
3. THE CONTRACTOR SHALL BE RESPONSIBLE TO INVESTIGATE AND VERIFY THE ACTUAL LOCATION AND DEPTH OF ALL EXISTING UNDERGROUND FACILITIES AT LEAST 48 HOURS IN ADVANCE OF THE PERFORMANCE OF ANY WORK. CALL (USA) UNDERGROUND SERVICE ALERT. TEL#: 800-227-2600 BEFORE TRENCHING
4. CONTRACTOR TO BE COGNIZANT OF (H.V.) UG UTILITY LINE PRIOR TO EXCAVATION. COORDINATE WITH UTILITY CO AS NECESSARY PRIOR TO TRENCHING.
5. REPAIR TRENCH LINE TO MATCH (E) SURFACE, TYP. UON.
6. CONFIRM CONDUIT SIZE AND QUANTITY WITH DRAWING E3-PE.

KEYNOTES


- 1 PROVIDE CODE SIZE PULL BOX, SUITABLE FOR TRAFFIC LOADING, COMPLETED WITH EXTENSION AND STEEL COVER, COORDINATE EXACT LOCATION IN THE FIELD.
- 2 FOR ELECTRICAL SIGNAGE AND LOCATION SEE DWG. E11.
- 3 SEE ARCH. DWG. FOR EXACT LOCATION.

CONDUIT SCHEDULE

TAG	CONDUIT	FROM	TO
F1	(1) 2" C	CB "A1"	EQUIP PAD
F2	(1) 1" C	CB "A2"	EQUIP PAD
F3	(1) 1-1/4" C	CB "A3"	EQUIP PAD
F4	(1) 3/4" C	CB "A4"	EQUIP PAD
F5	(1) 1" C	MET STATION	DAS
F6	(1) 2-1/2" C	EQUIP PAD	TIE-IN LOCATION

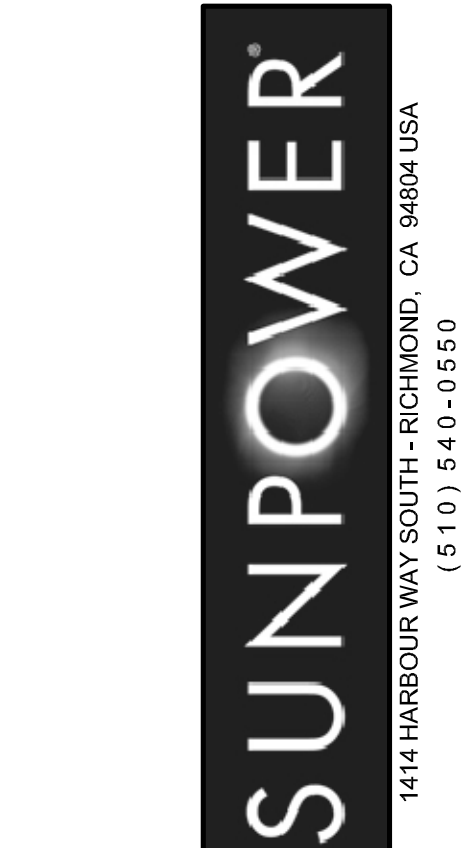

ITEM	REVISIONS/ISSUE	DATE
1	DSA REVIEW	XX/XX/XX
	PG&E SUBMITTAL	10/12/11

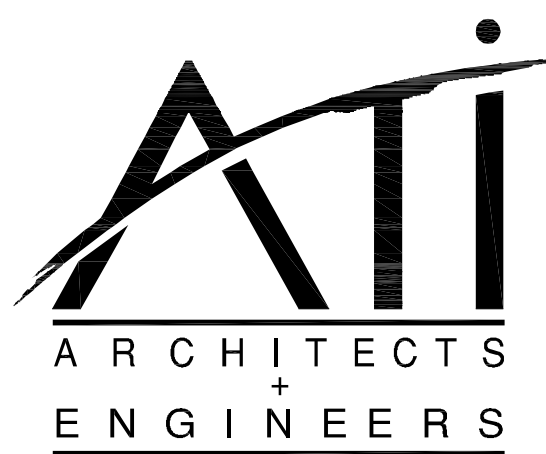

www.atiae.com


3860 Blackhawk Road  
Danville, CA 94505  
T 925.648.8800

2510 Douglas Boulevard  
Roseville, CA 95661  
T 916.772.1800

3050 Pullman Street  
Costa Mesa, CA 92626  
T 714.338.1600

1901 Orange Tree Lane  
Redlands, CA 92374  
T 909.801.8160

PROFESSIONAL STAMP:

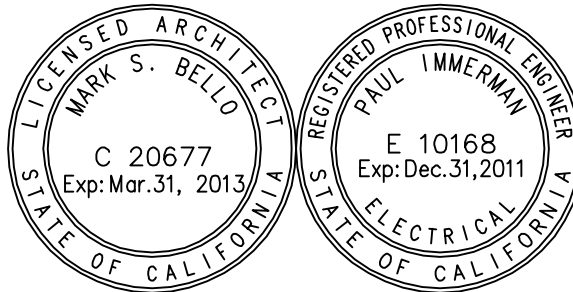

APPROVALS:

PROJECT TITLE:

**SUNPOWER  
ELEVATED  
SOLAR CANOPY  
PLEASANT HILL  
ELEMENTARY  
MT. DIABLO UNIFIED  
SCHOOL DISTRICT**

SHEET TITLE:

**ELECTRICAL  
SITE  
PLAN**

DATE:

10/12/11

SCALE:

AS NOTED

DRAWN BY:

JAG/AR

CHECKED BY:

PMI

JOB NO:

SA8504.048

CAD FILE:

+E1\_PE\_Site.dwg

SHEET NO:

**E1-PE**